



MIAMI DADE WATER AND SEWER DEPARTMENT

3071 S.W. 38th AVENUE MIAMI, FL 33146-1520


DRY WELL SEWAGE PUMPING STATION WITH EMERGENCY GENERATOR

PUMPING STATION No. 0000

PROJECT OFFICIAL ADDRESS MIAMI, FL 33000-0000

PCTS 00000

CONTRACT X-000 or RPQ/ ER X00000

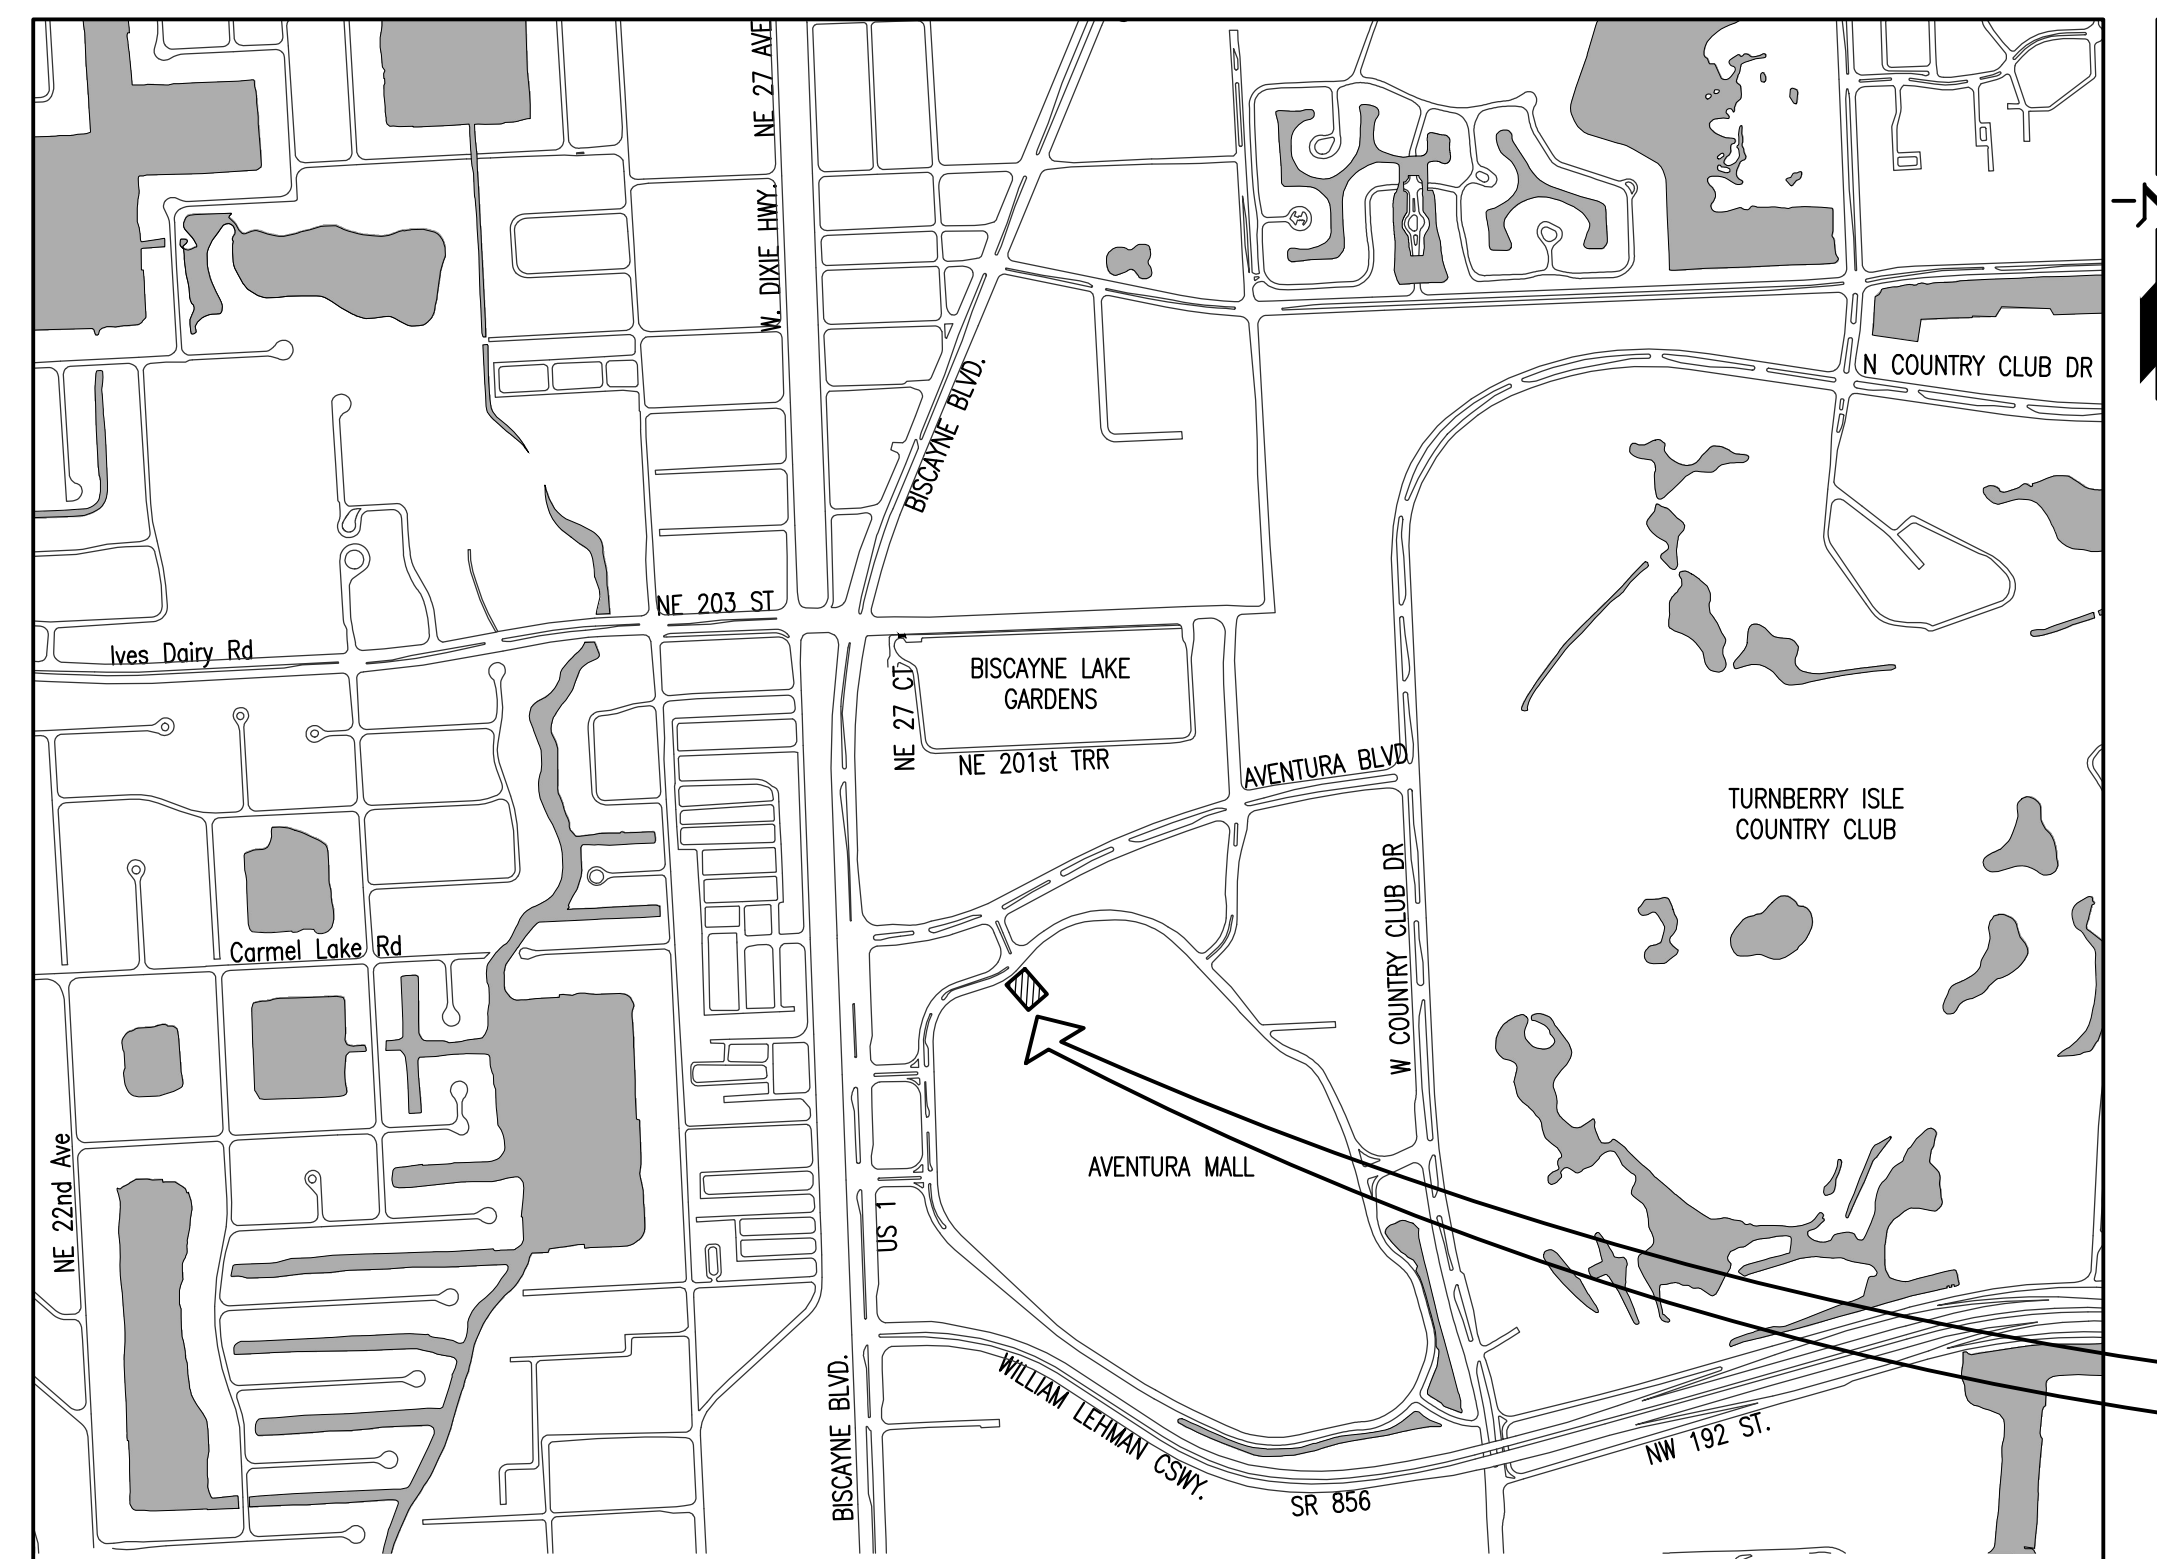

LOCATION PLAN

SCALE: X"=X'-X"

CITY NAME or MIAMI-DADE COUNTY
T50-S40-R00
FOLIO 00-0000-000-0000

SHEET INDEX

- C-1 COVER SHEET
- C-2 SITE PLAN, LEGEND AND NOTES
- M-1 MECHANICAL PLAN, SECTIONS, DETAILS AND PUMP DATA
- M-2 SAMPLE-FUEL STORAGE TANK PLAN AND DETAILS
- E-1 ELECTRICAL GENERAL NOTES
- E-2 ELECTRICAL SITE PLAN AND NOTES
- E-3 ELECTRICAL ONE LINE DIAGRAM
- E-4A CONTROL WIRING DIAGRAM (STATION CONTROLLER SC2000)
- E-4B CONTROL WIRING DIAGRAM (MULTISMART PUMP STATION MANAGER)
- E-5 ELECTRICAL CONTROL PANEL AND DETAILS
- E-6 R.T.U. INSTALLATION WIRING DIAGRAMS
- E-7 ELECTRICAL RISER & EMERGENCY GENERATOR BLDG. FLOOR PLAN
- A-1 EMERGENCY GENERATOR BUILDING FLOOR PLAN, SECTIONS AND ELEVATIONS
- S-1 STRUCTURAL GENERAL NOTES
- S-2 WET WELL AND VAULT VALVE STRUCTURAL PLAN, SECTIONS AND DETAILS
- S-3 FOUNDATION/SUPPORT FOR ELECTRICAL INSTALLATIONS
- S-4 CHAIN LINK FENCE AND GATES
- S-5 EMERGENCY GENERATOR BUILDING FOUNDATION PLAN, ROOF PLAN, SECTIONS AND DETAILS



Know what's below.
Call before you dig.

S.S.O.C.O.F. TICKET No. XXXXXXXX
DATE: xx/xx/2014
FIELD BOOK XXXX, PAGES XXXXX

Xxxx X. Xxxxx, P.E.
Engineer of Record
State of Florida - License No.00000
3575 S. Le Jeune Rd. Miami, FL 33146
WASD (786) 268-0000
Date: _____

Xxxx X. Xxxxx
Project Manager
ENGINEERING & DESIGN DIVISION
3575 S. Le Jeune Rd. Miami FL 33146
WASD (786) 268-0000
Date: _____

APPROVALS	DRAWING HISTORY	DATE	BY	No.	REVISION	DATE	BY	FILE NAME: XXXXXC01.DWG
SR. PROG. MGR.: X.X.X.	X REVIEW 90%	xx/xx/19	xxx	△	XXXXXX XXXXXX	xx/xx/19	xxx	DATE: 01/01/18 DRAWN: X.X.X.
PROJECT MGR.: X.X.X.								SHEET C-1 OF 000
SPEC. WRITER: X.X.X.								DWG. No. S-00000-D