
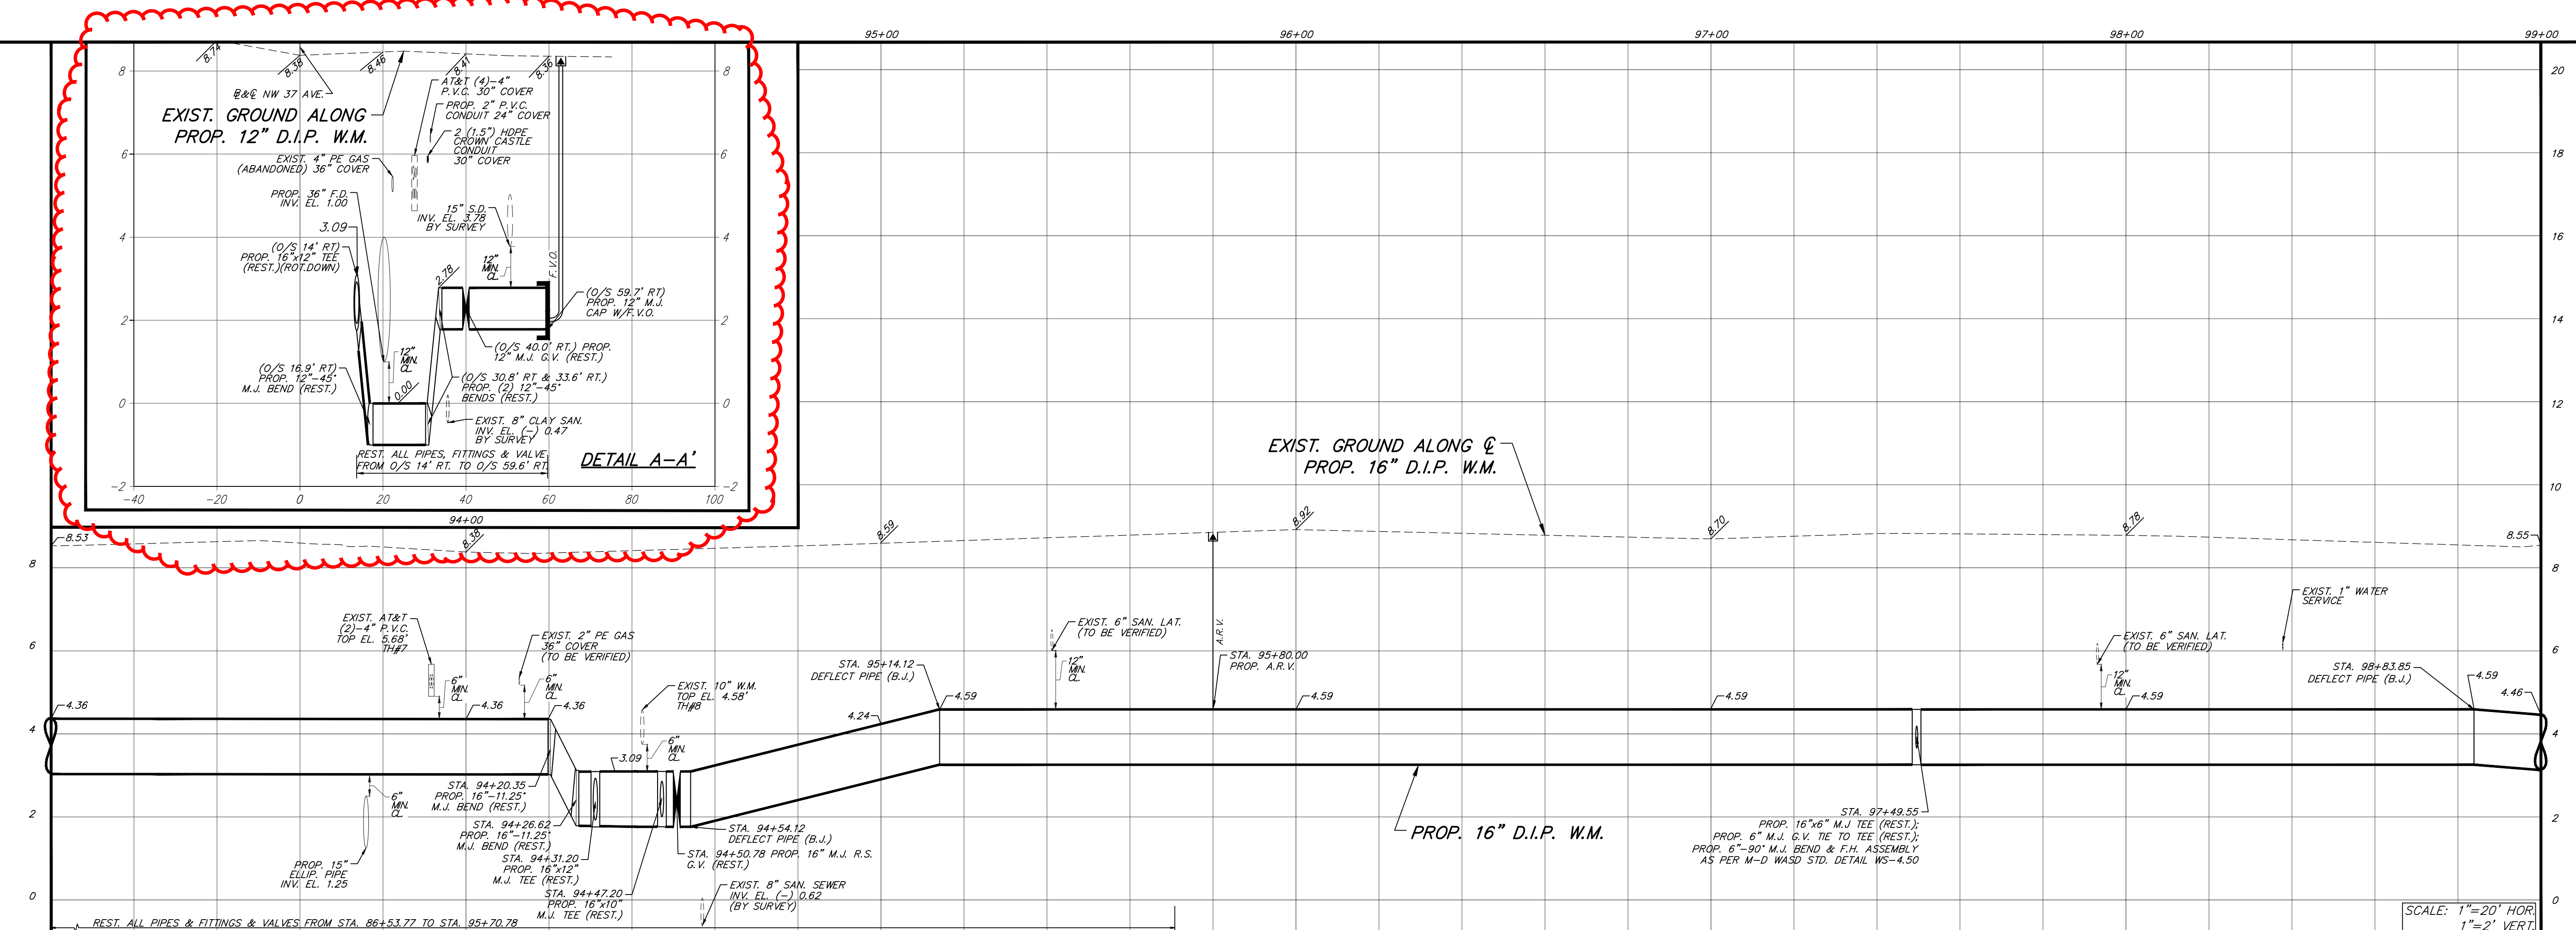


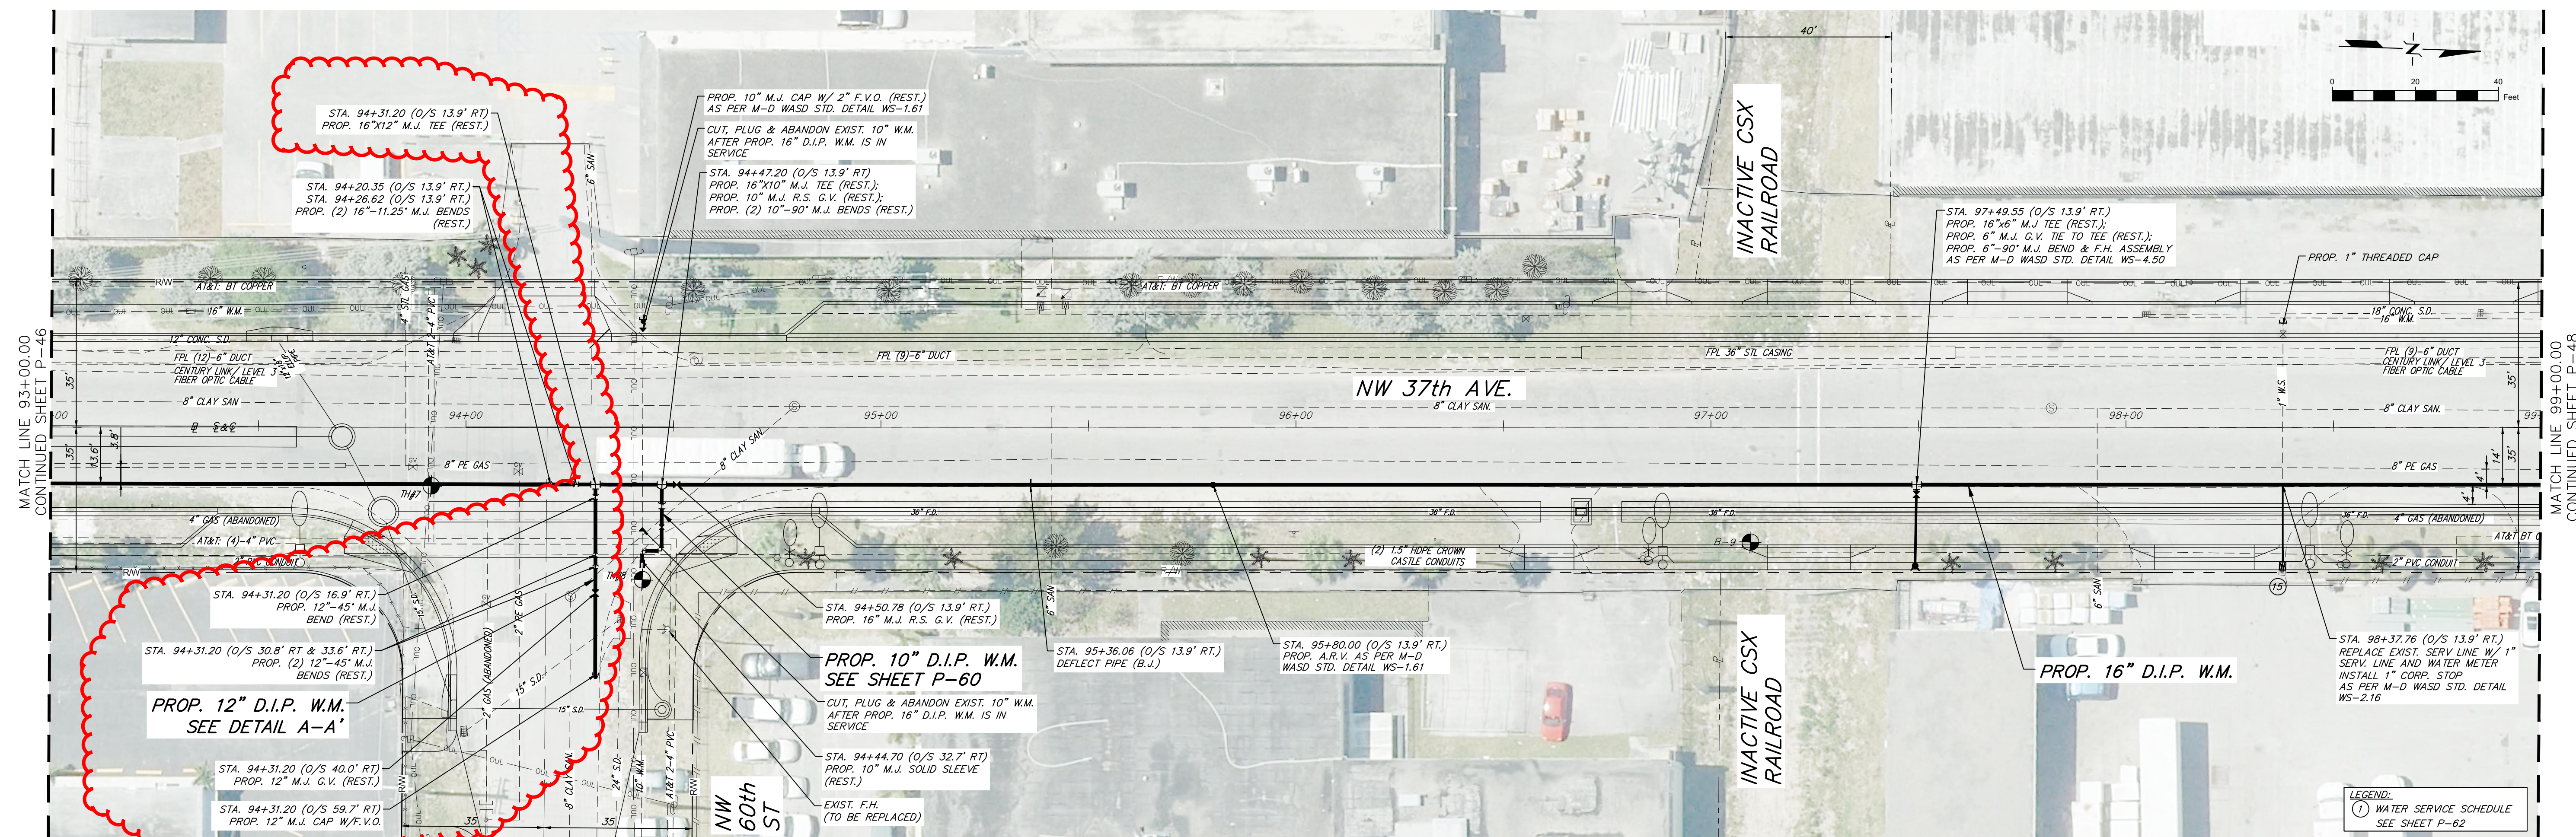

PROPOSED 16-INCH WATER MAIN ALONG NW 37th AVENUE,
FROM NW 36th STREET TO NW 82nd STREET.
ISD PROJECT No. E15-WASD-03B
ER W017329; PCTS No. 16054
PLAN AND PROFILE



DRAWING HISTORY			
RELEASED FOR		DATE	BY
1	30% SUBMITTAL	01/15/20	A.A
2	90% SUBMITTAL	05/15/20	A.A
3	PERMIT SUBMITTAL	10/07/20	A.A
4	100% SUBMITTAL	03/03/21	A.A


REVISIONS			
No.	DESCRIPTION	DATE	BY

APPROVALS	
PROJECT MGR: A.A.	CHECKED: A.A.
DESIGNED: I.P.	DRAWN: V.M.
CHIEF ENGINEER:	
SECTION HEAD:	
DESIGN MGR.:	


ARNELIO ALFONSO, P.E.
CIVIL ENGINEER
 State of Florida - License No. 52568
 8935 NW 35th LN, SUITE 200,
 MIAMI FL. 33172
 (305) 592-7283

FILE NAME: 047_Plan&Profile_14.dwg	
DATE: 03/03/2021	SCALE: 1"=20'
SHEET P-47 OF 145	
DWG. No.	

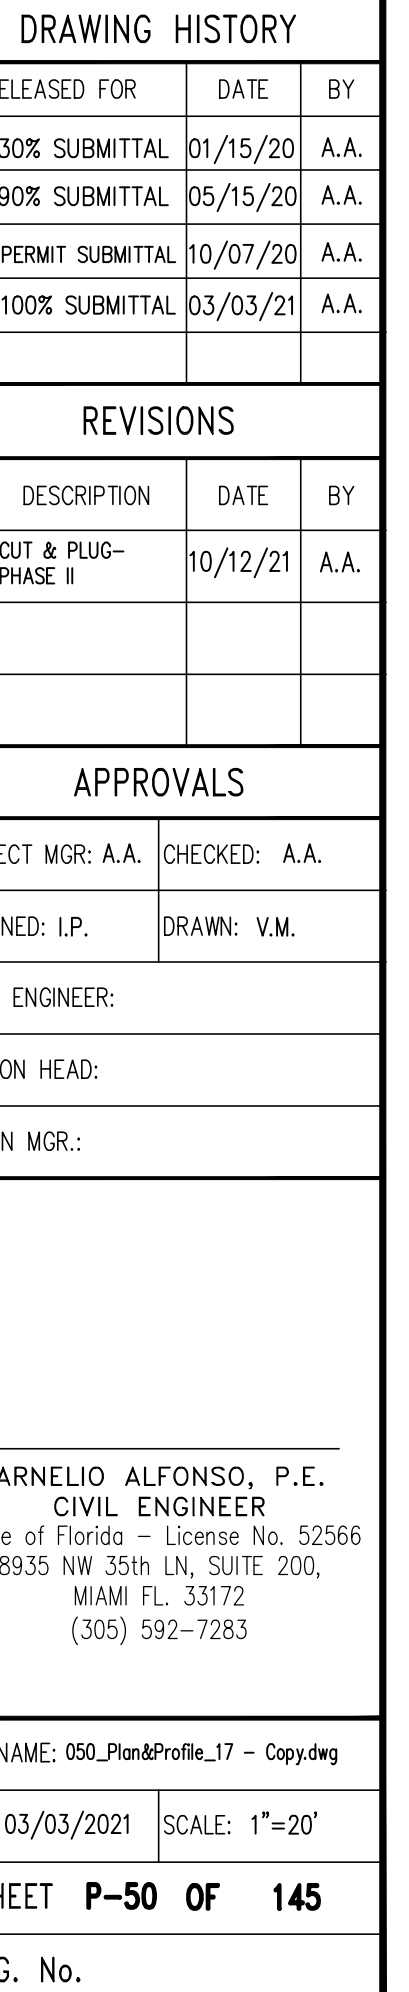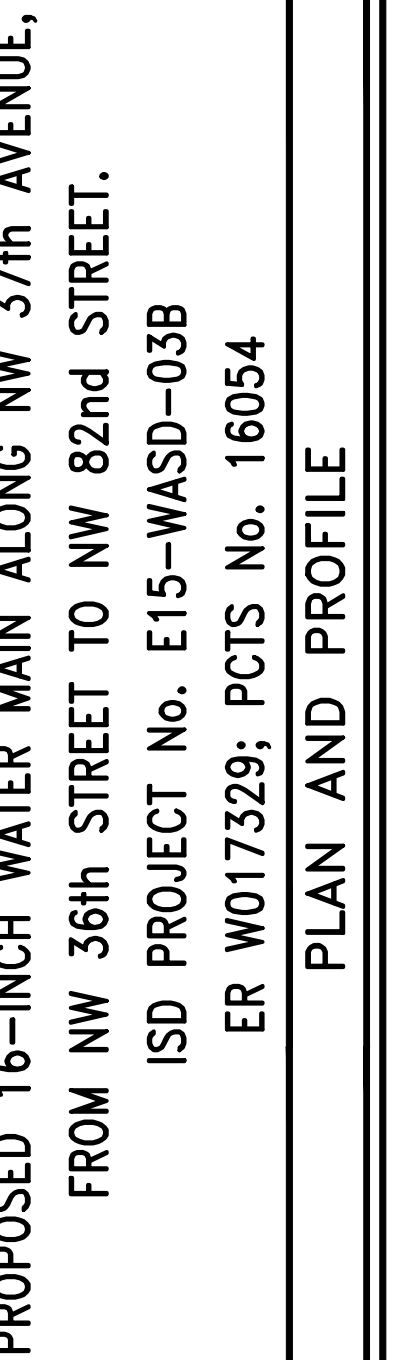

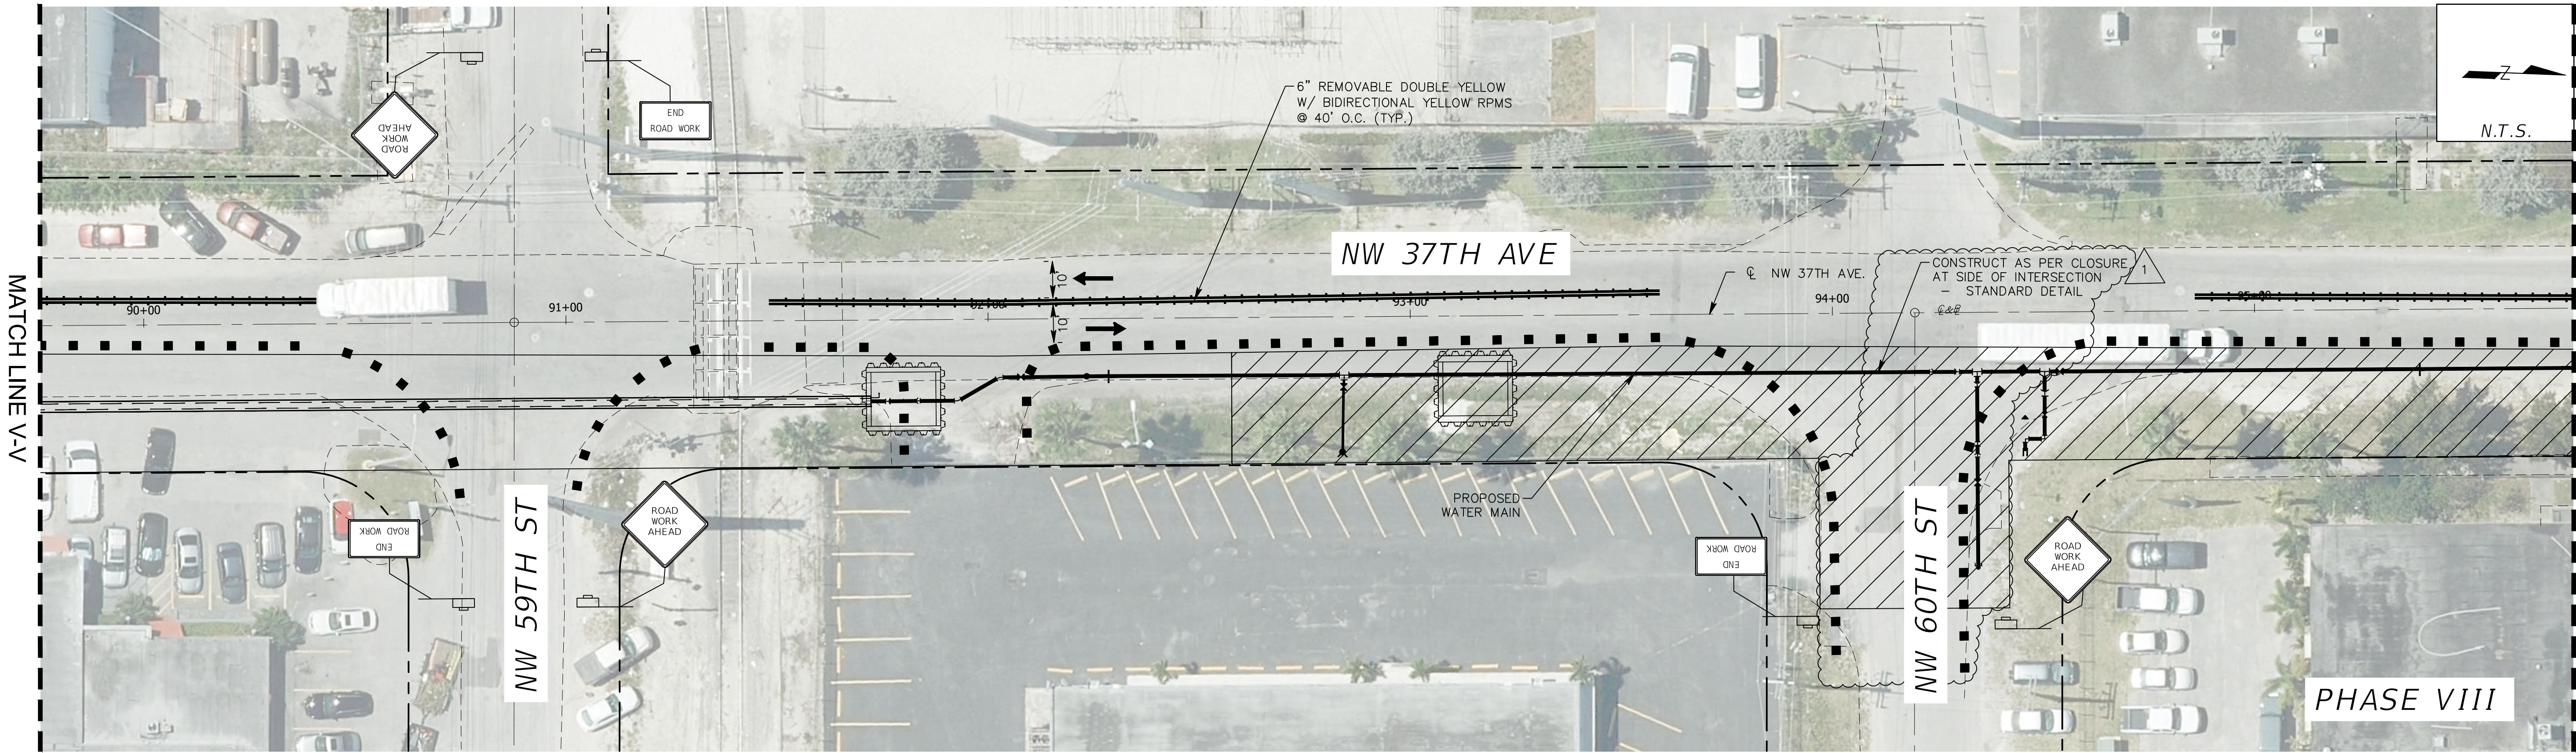

- LEGEND:**
- WORK AREA
 - TYPE III BARRICADE
 - WORK ZONE SIGN
 - TYPE I OR TYPE II CHANNELIZING DEVICE
 - PED. LONGITUDINAL CHANNELIZING DEVICE
 - DIRECTION OF TRAFFIC
 - PED. LONGITUDINAL CHANNELIZING DEVICE WITH MOUNTED WORK ZONE SIGN

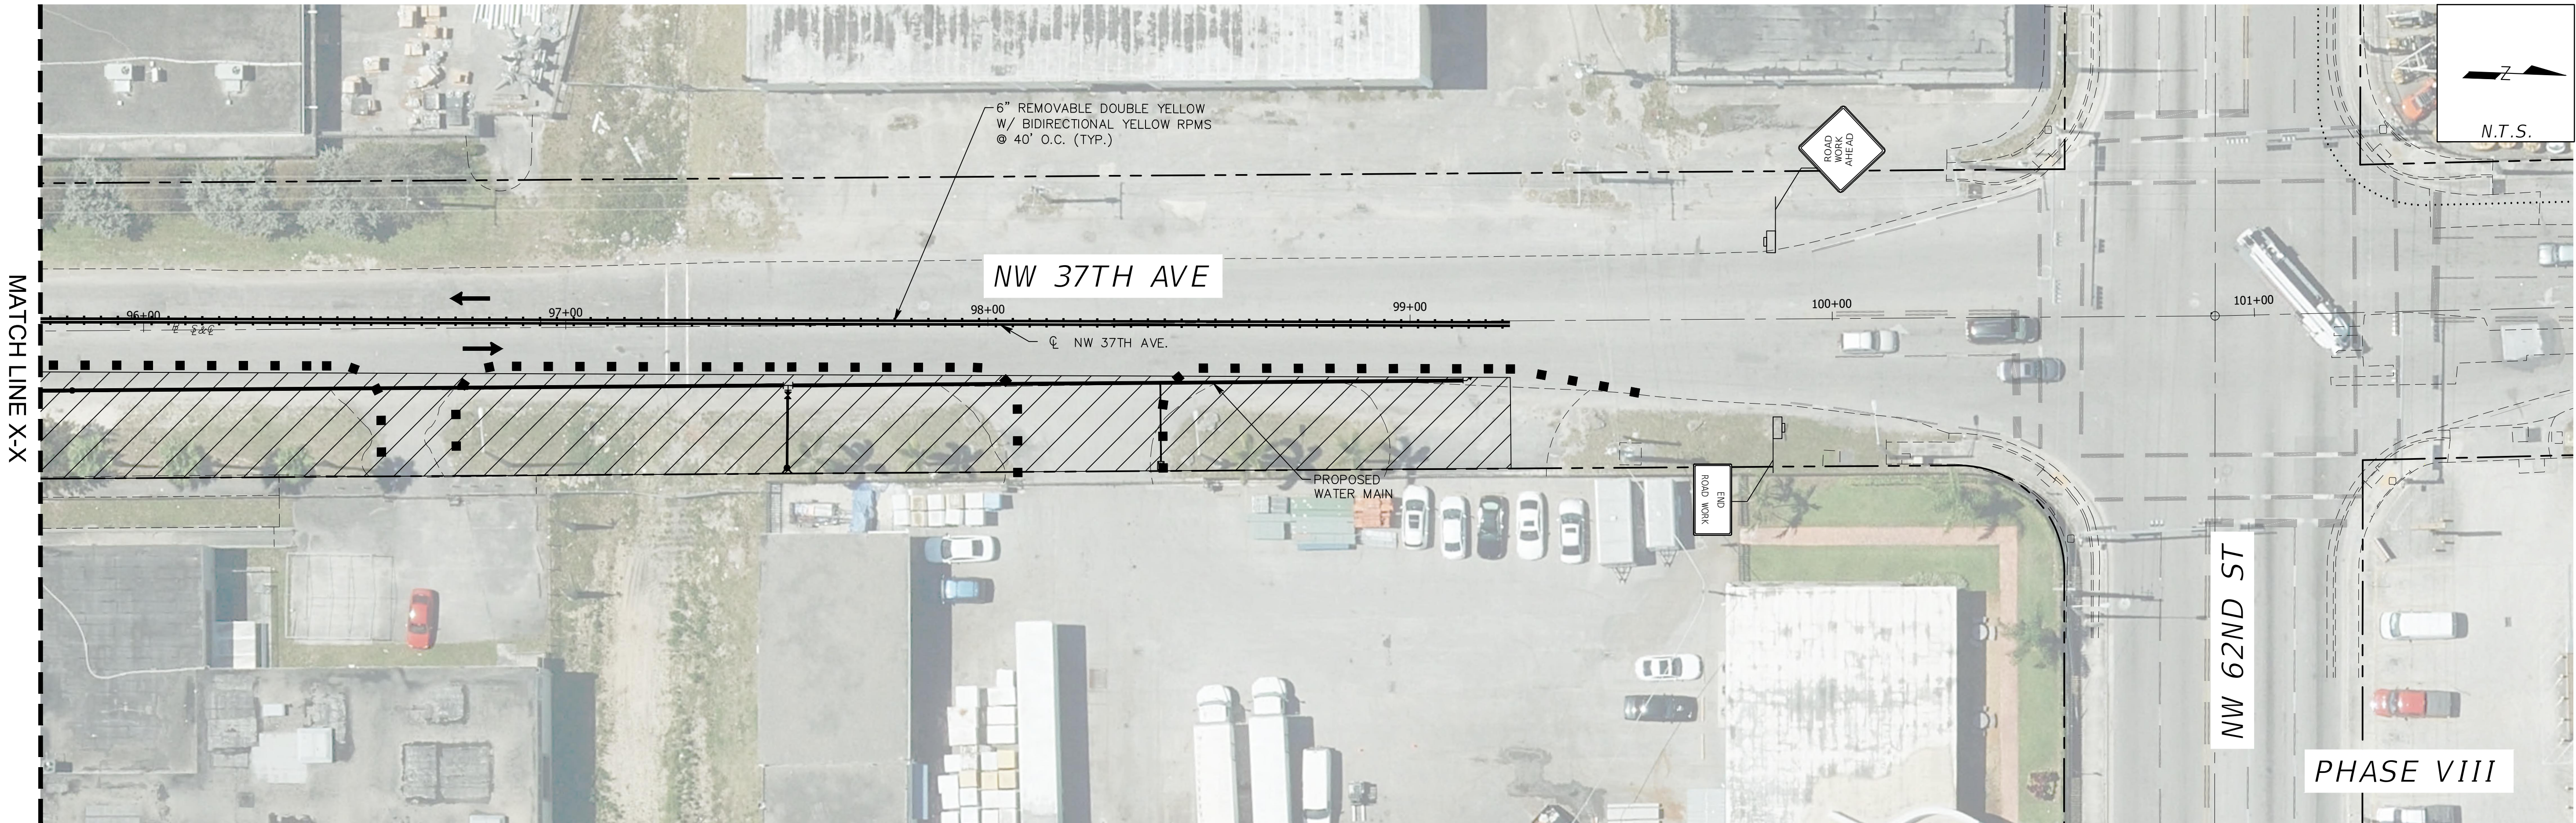

MIAMI-DADE COUNTY
Delivering Excellence Every Day
WATER & SEWER DEPARTMENT
3575 S. LE JEUNE RD.
MIAMI, FL 33133
305-665-7471
www.miamidade.gov/water

A&P ENGINEERS
CA No.: EB-0007797
8835 NW 35th STREET, SUITE 200
MIAMI, FL 33172
305-592-7283
www.apcte.com

HBC Engineering Company
CA No.: 27160
8935 NW 35th STREET, SUITE 201
MIAMI, FL 33172
305-232-7932
www.hbcengineeringco.com

PROPOSED 16-INCH WATER MAIN ALONG NW 37th AVE.
FROM NW 36th STREET TO NW 82nd STREET
ISD PROJECT No. E15-WASD-03B
ER W017329; PCTS No. 16054
TEMPORARY TRAFFIC CONTROL PLAN

DRAWING HISTORY

RELEASED FOR	DATE	BY
1 90% SUBMITTAL	05/14/20	H.L.
2 PERMITTING	10/07/20	H.L.
3 100% SUBMITTAL	03/05/21	H.L.

REVISIONS

No.	DESCRIPTION	DATE	BY
1	ADDENDUM #1	08/27/21	D.O.

APPROVALS

PROJECT MGR:	CHECKED: H.L.
DESIGNED: J.F.	DRAWN: J.F.
CHIEF ENGINEER:	
SECTION HEAD:	
DESIGN MGR.:	

HERNAN A. LUGO, P.E.
CIVIL ENGINEER
State of Florida - License No. 74961
8935 NW 35th LN, SUITE 201,
MIAMI FL 33172
(305) 232-7932

FILE NAME:
TCD5R017 PHASE VIII.dwg
DATE: 03/03/2021 SCALE: AS SHOWN
SHEET P-95 OF 171
DWG. No.